



Light & Ventilation

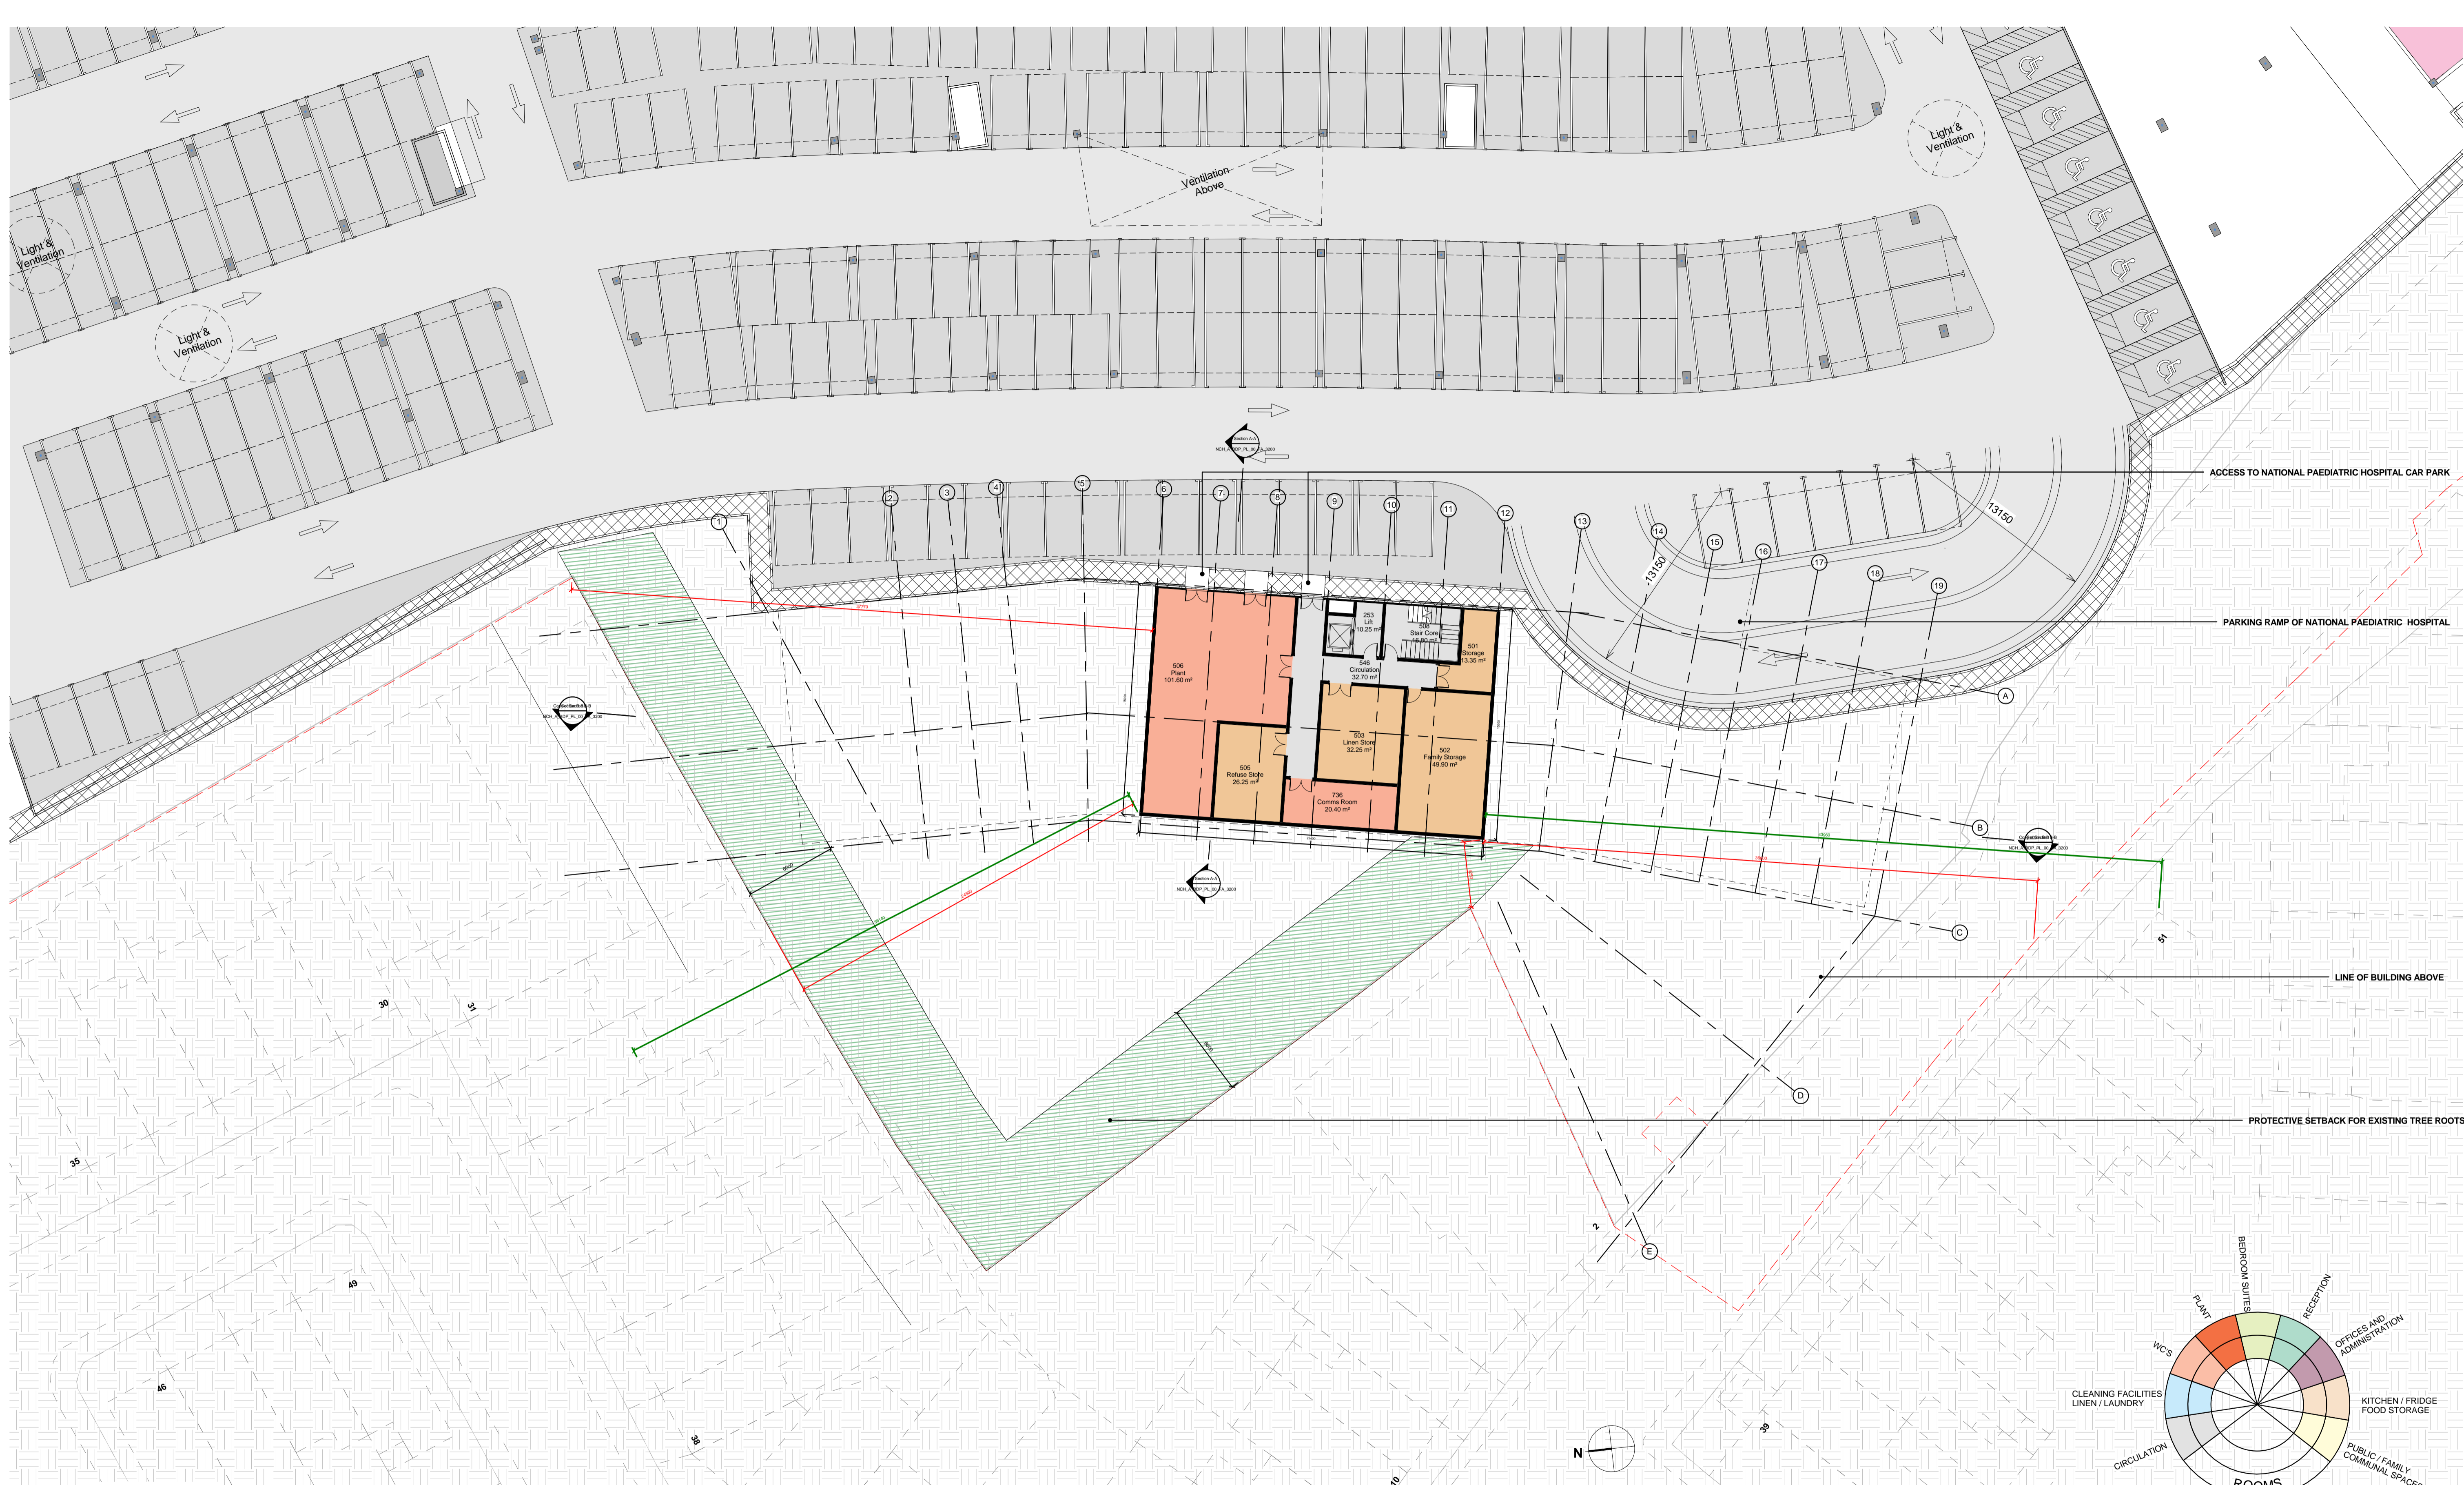

1 Level -01 Plan
1 : 200

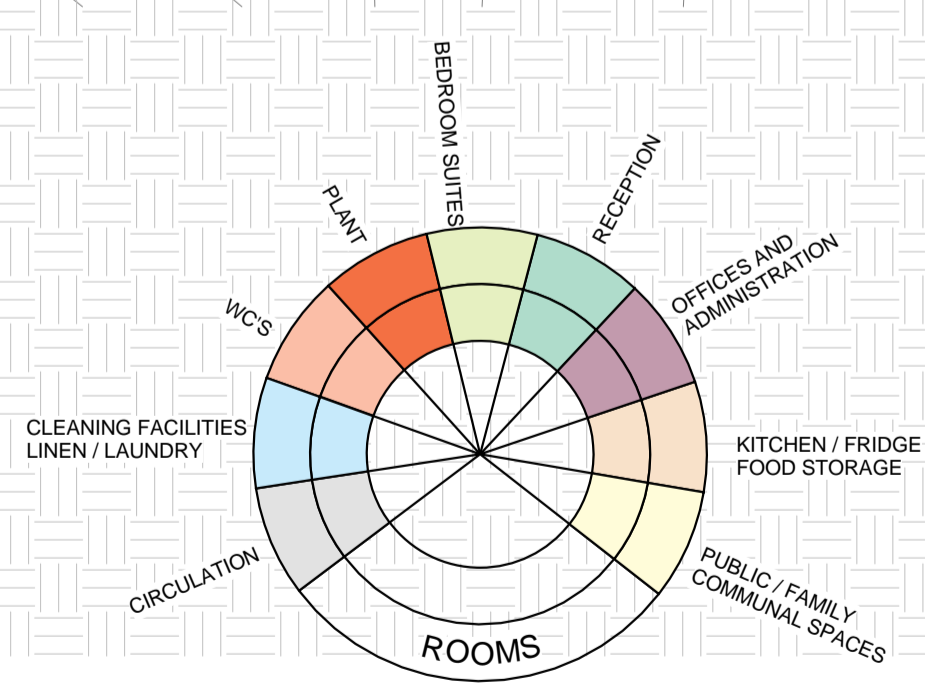

LEGEND											
SYMBOL / DESCRIPTION	SYMBOL	CHECKED	DATE	SYMBOL / DESCRIPTION	SYMBOL	CHECKED	DATE	SYMBOL / DESCRIPTION	SYMBOL	CHECKED	DATE

BDP.
 Blackhall Green
 Blackhall PI
 Dublin 7
 Ireland
 T +353 (1) 474 0600
 E dublin@bdp.com
 www.bdp.com

PROJECT TITLE Family Accommodation - NPH	
DESIGNED BY LEVEL LG - FLOOR PLAN	SCALE @ A1 1 : 200
STAGE 2A	DATE JULY 2015
DRAWING NO. NCH_A_BDP_PL_-1_FA_1205	